




PART. BURIED
PIPING PLAN
SCALE: 1/8"=1'-0"

NOTES

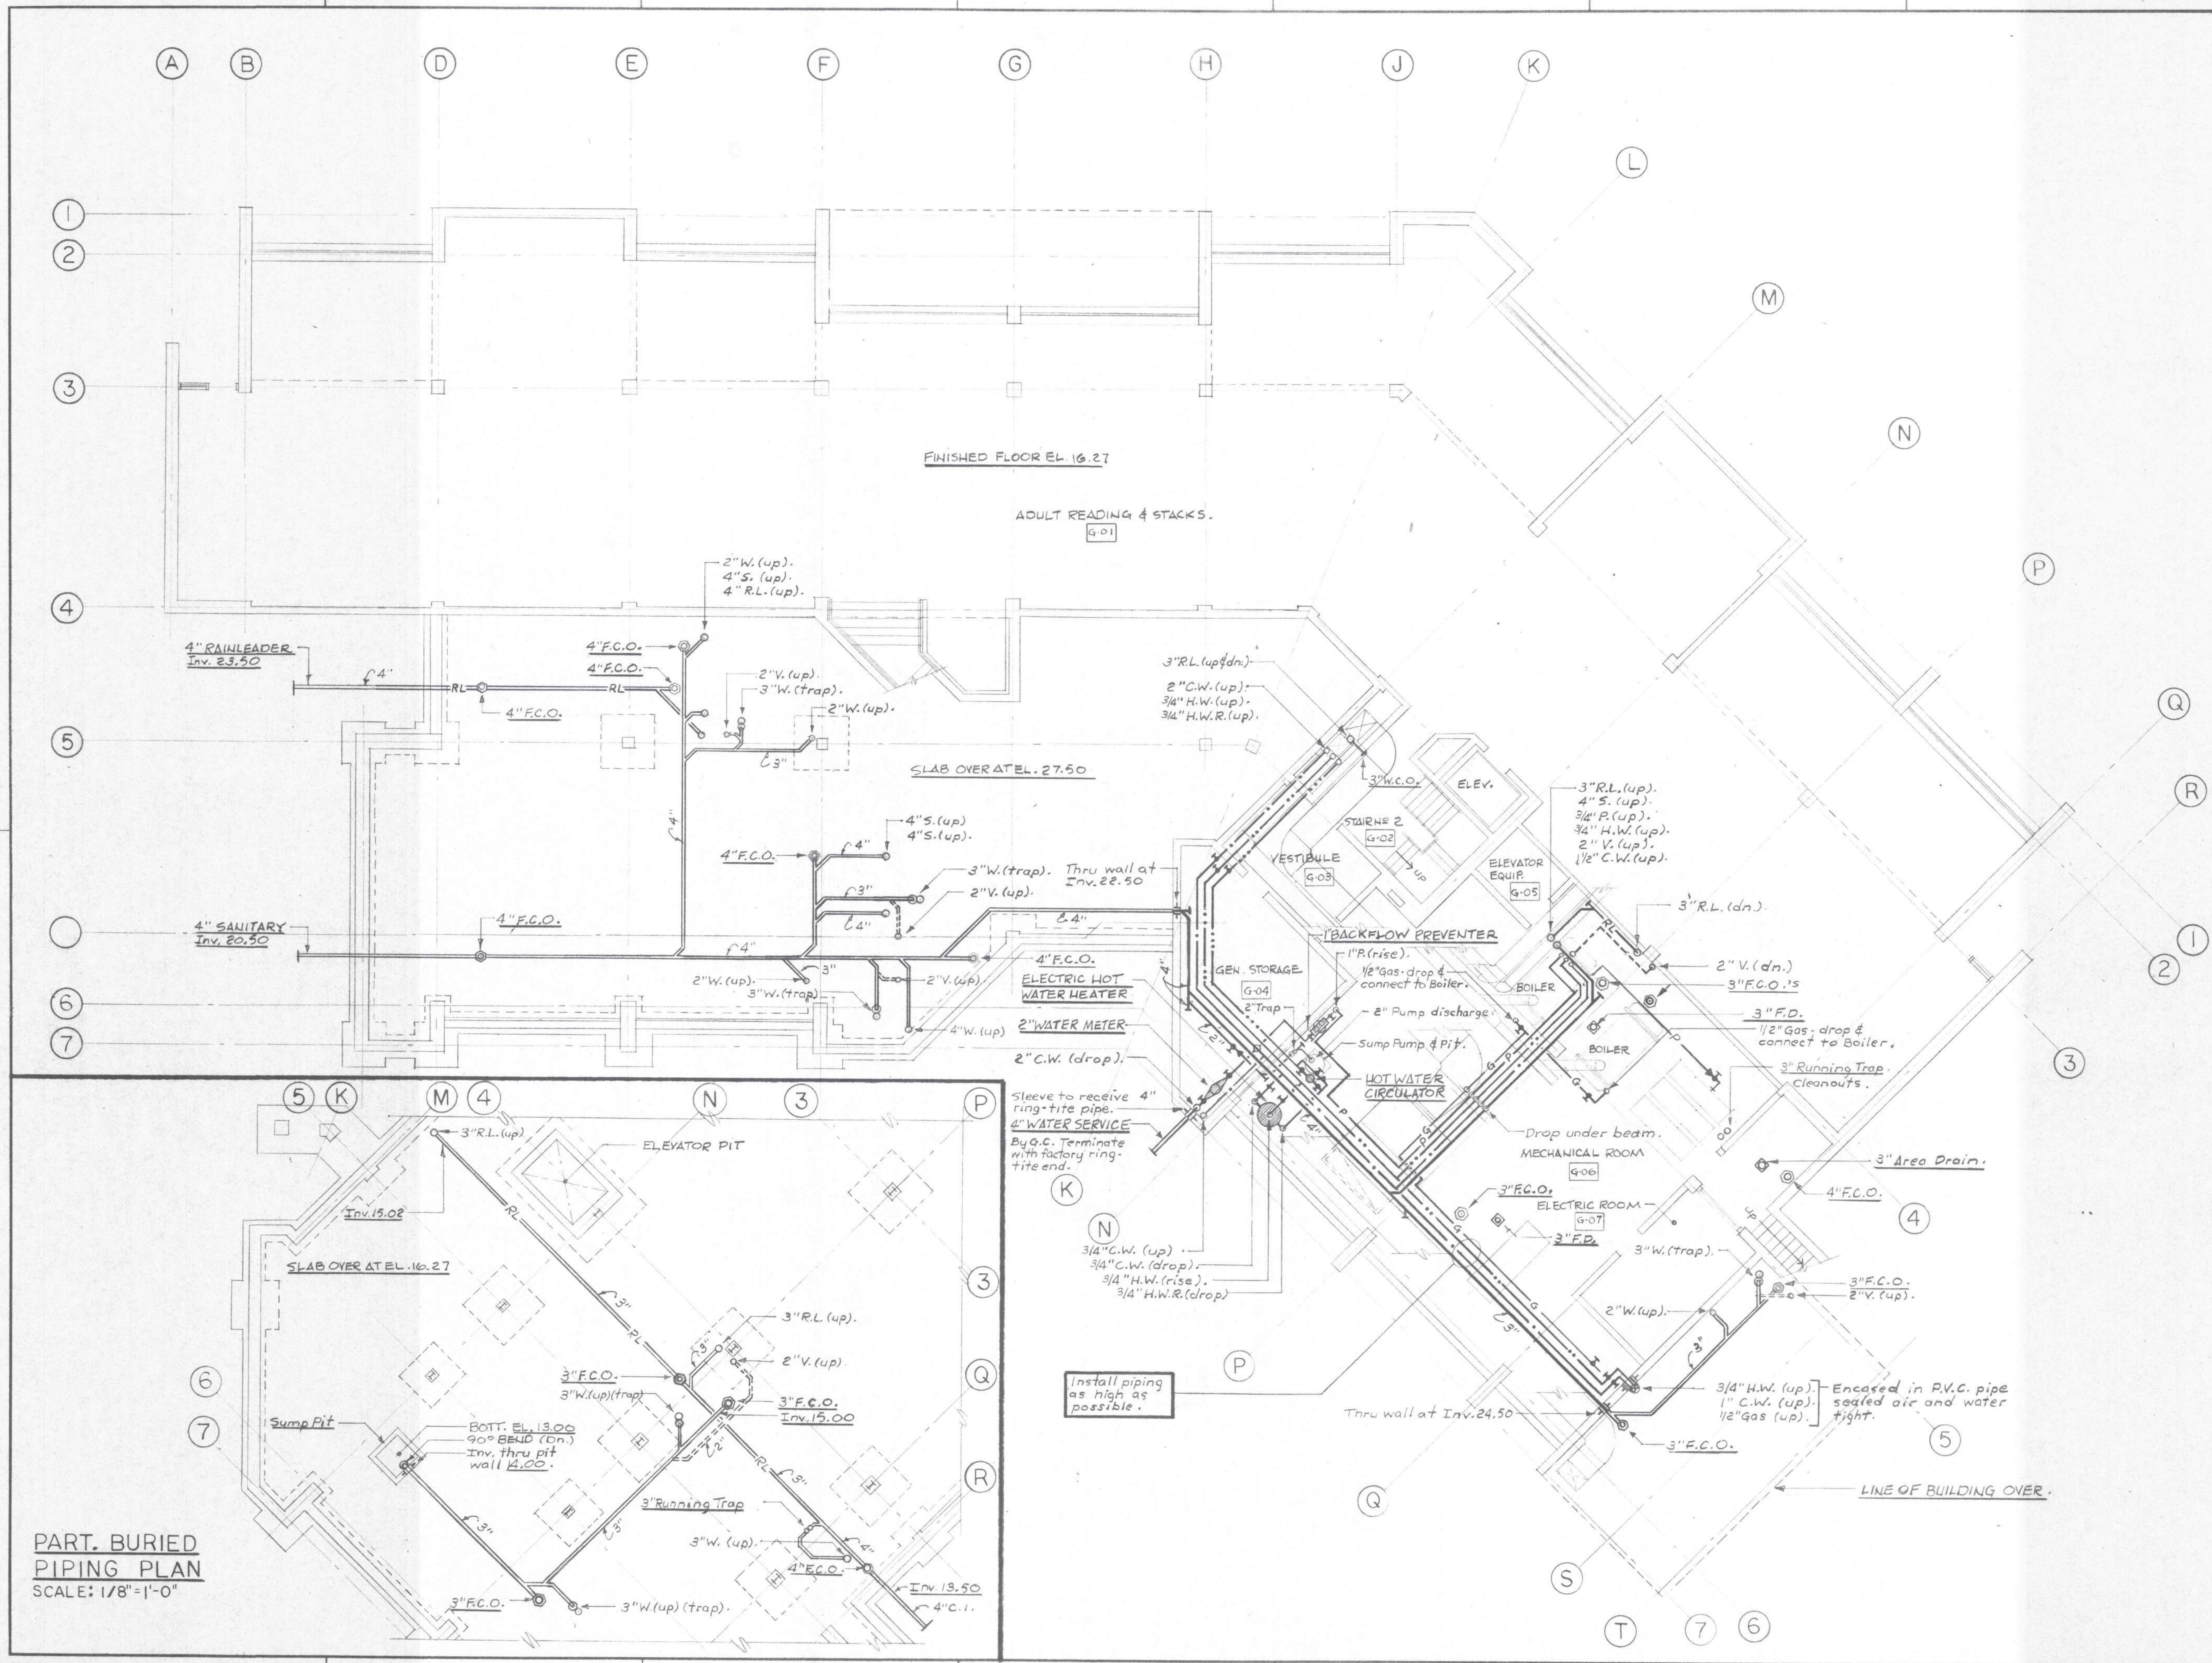

THE ARCHITECTS COLLABORATIVE INC.
46 BRATTLE STREET, CAMBRIDGE
MASSACHUSETTS 02138

PROJECT TITLE

**N. KINGSTOWN
FREE LIBRARY**


PROJECT NO.	73006
DRAWN	R.F.B.
CHECK	R.A.D.
SCALE	1/8"=1'-0"
DATE	
DRAWING TITLE	

LOWER LEVEL


DRAWING NO.

P 1


MARCH 7 181-34

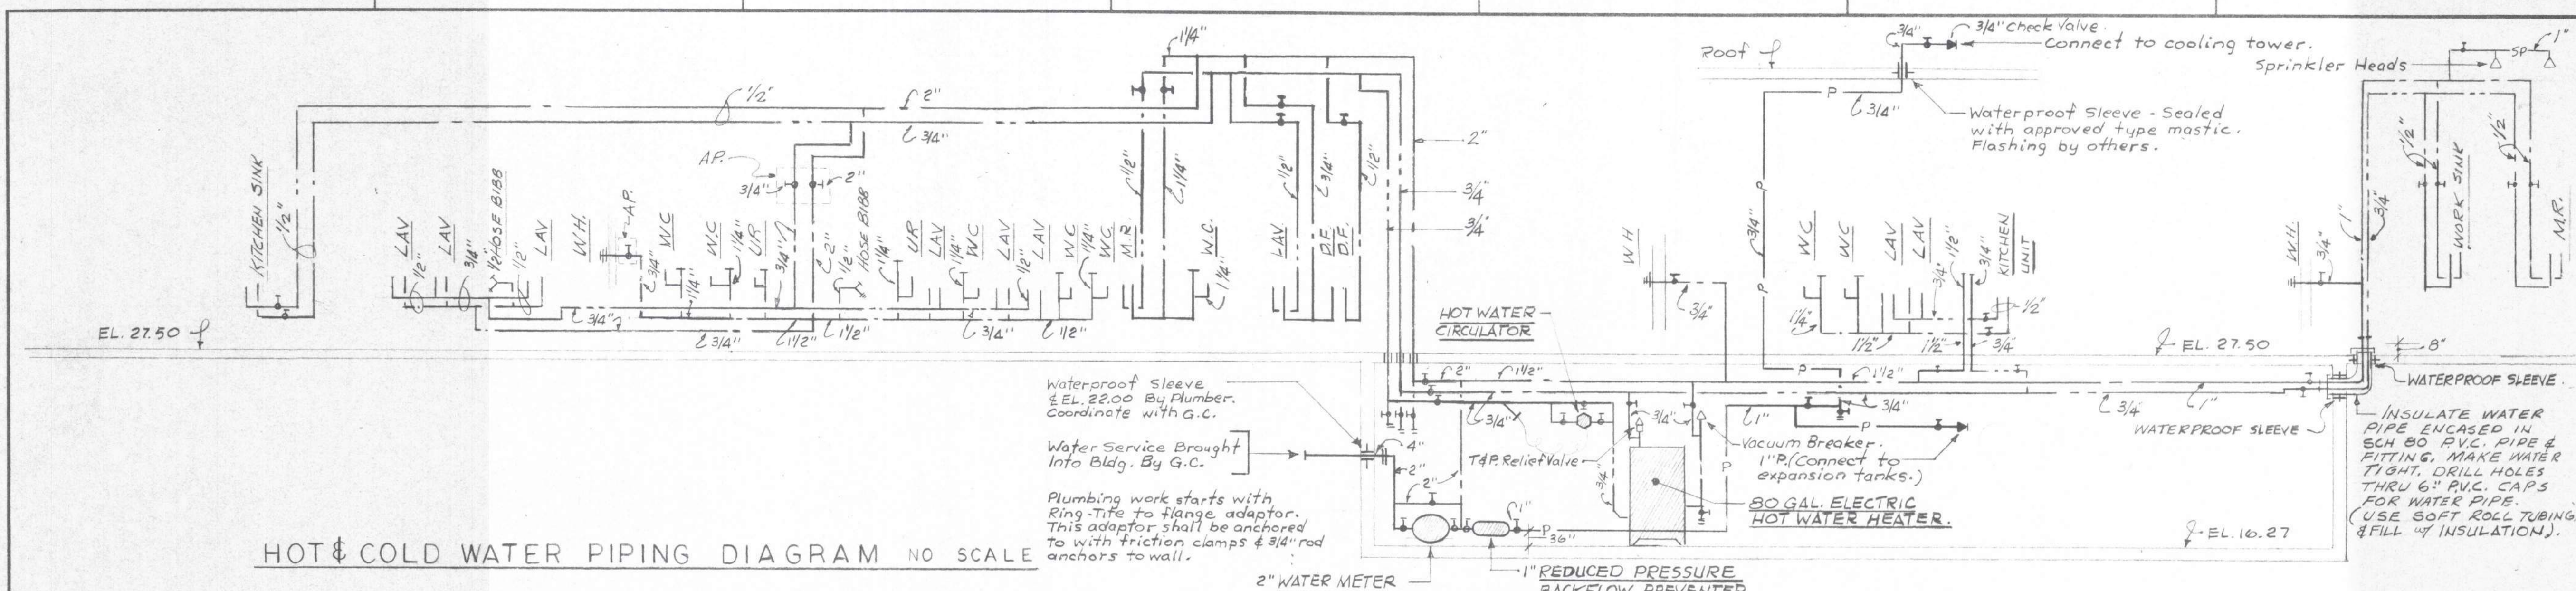


HOT & COLD WATER PIPING DIAGRAM NO SCALE

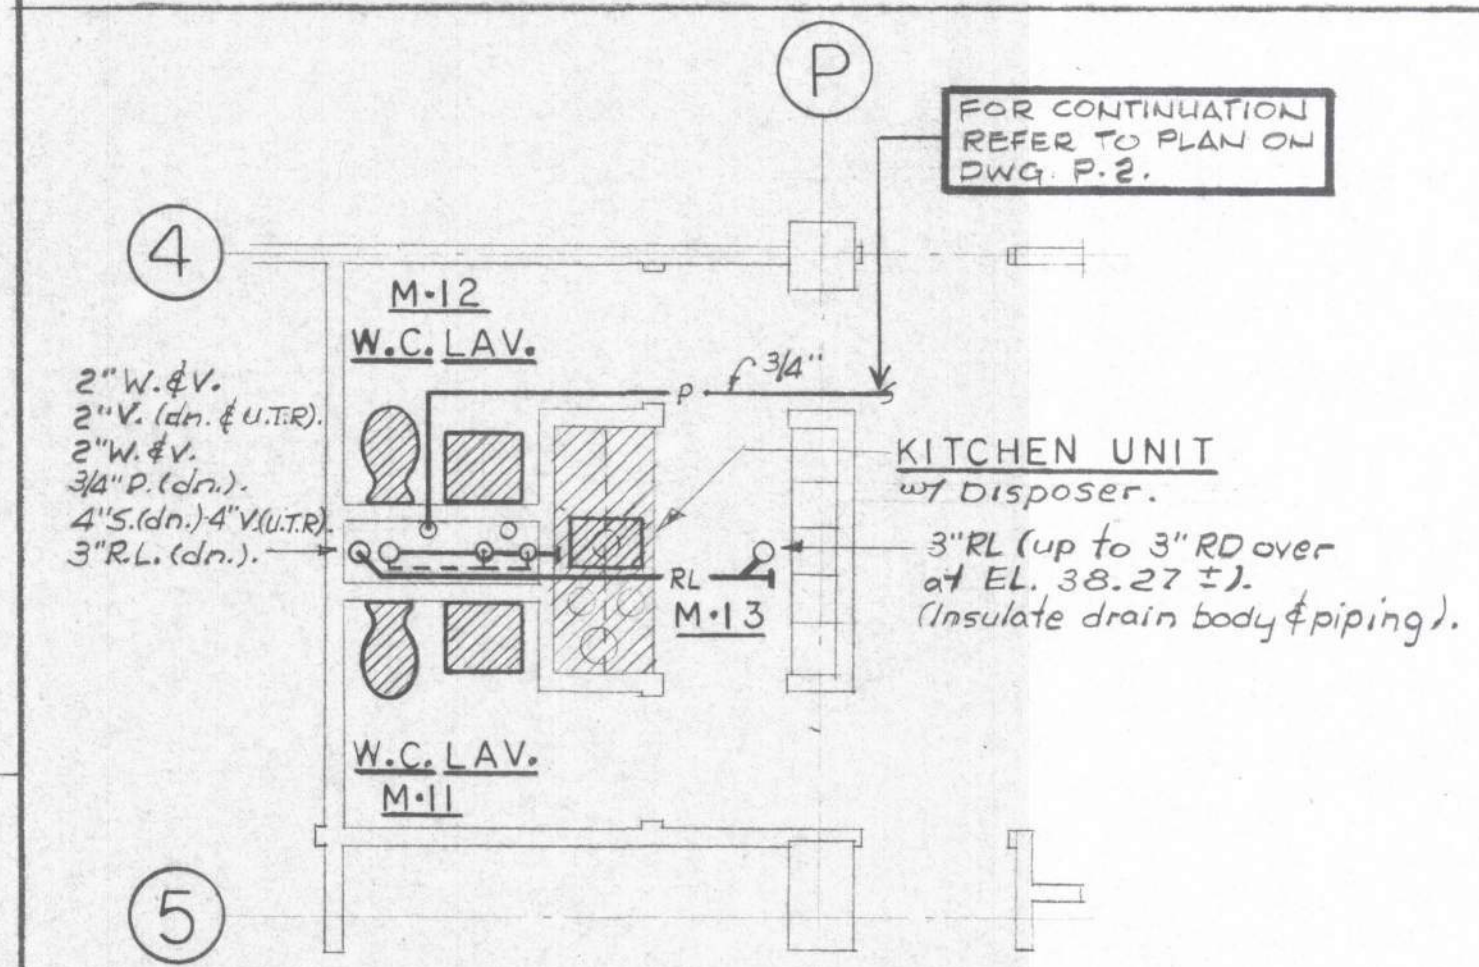


STAFF TOILET R.M.'S. & KIT. UNIT
SCALE: 1/4"=1'-0"

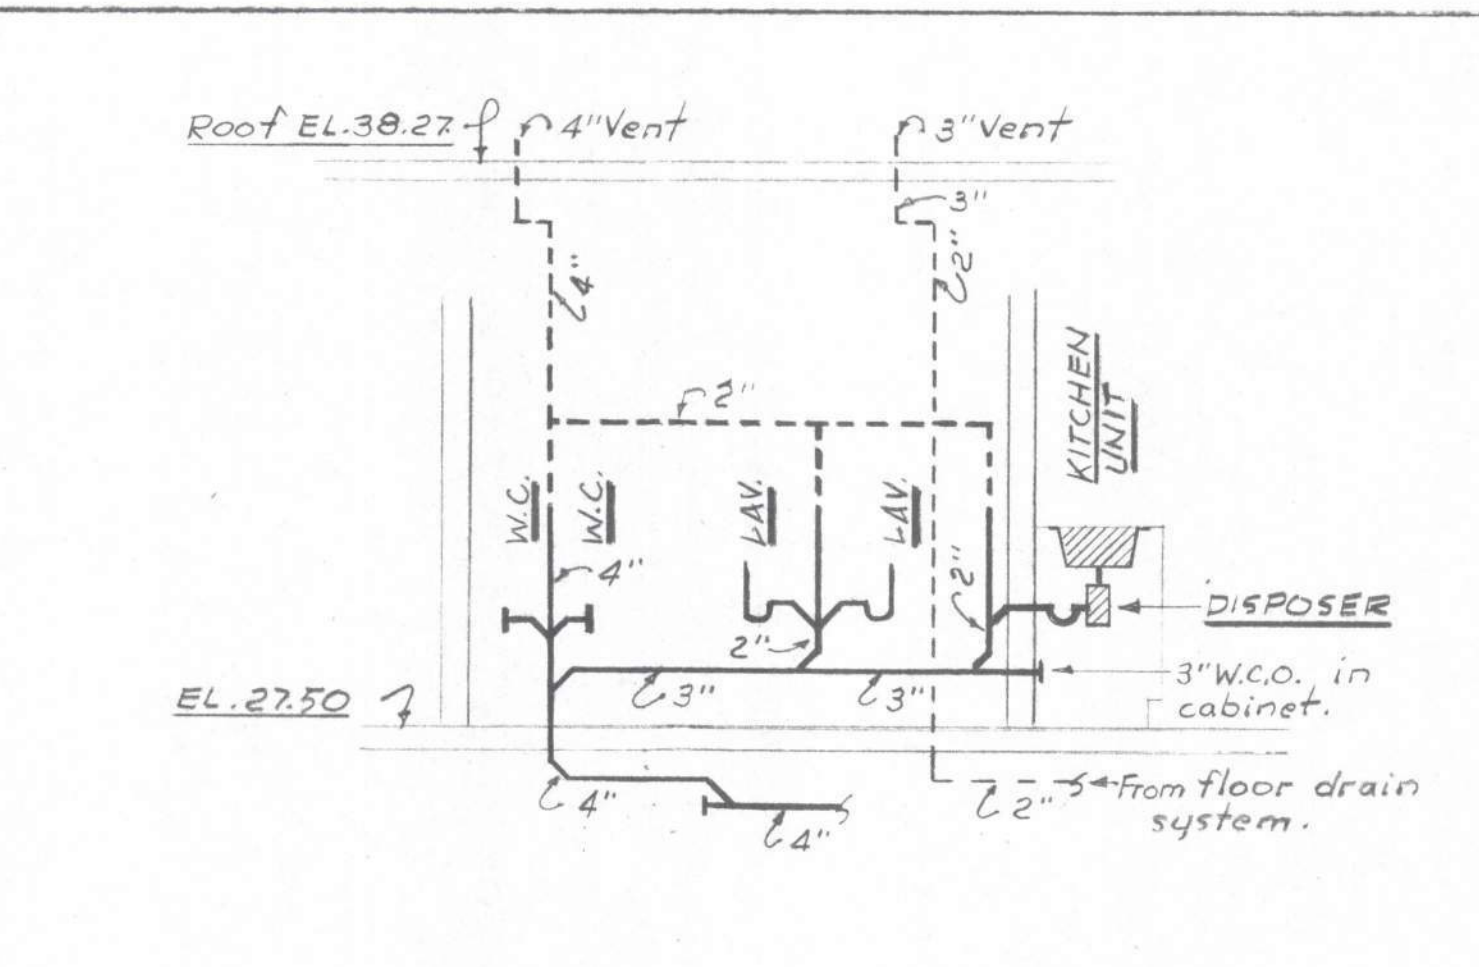

STAFF TOILET R.M.'S. & KIT. UNIT PIPING DIAGRAM
NO SCALE

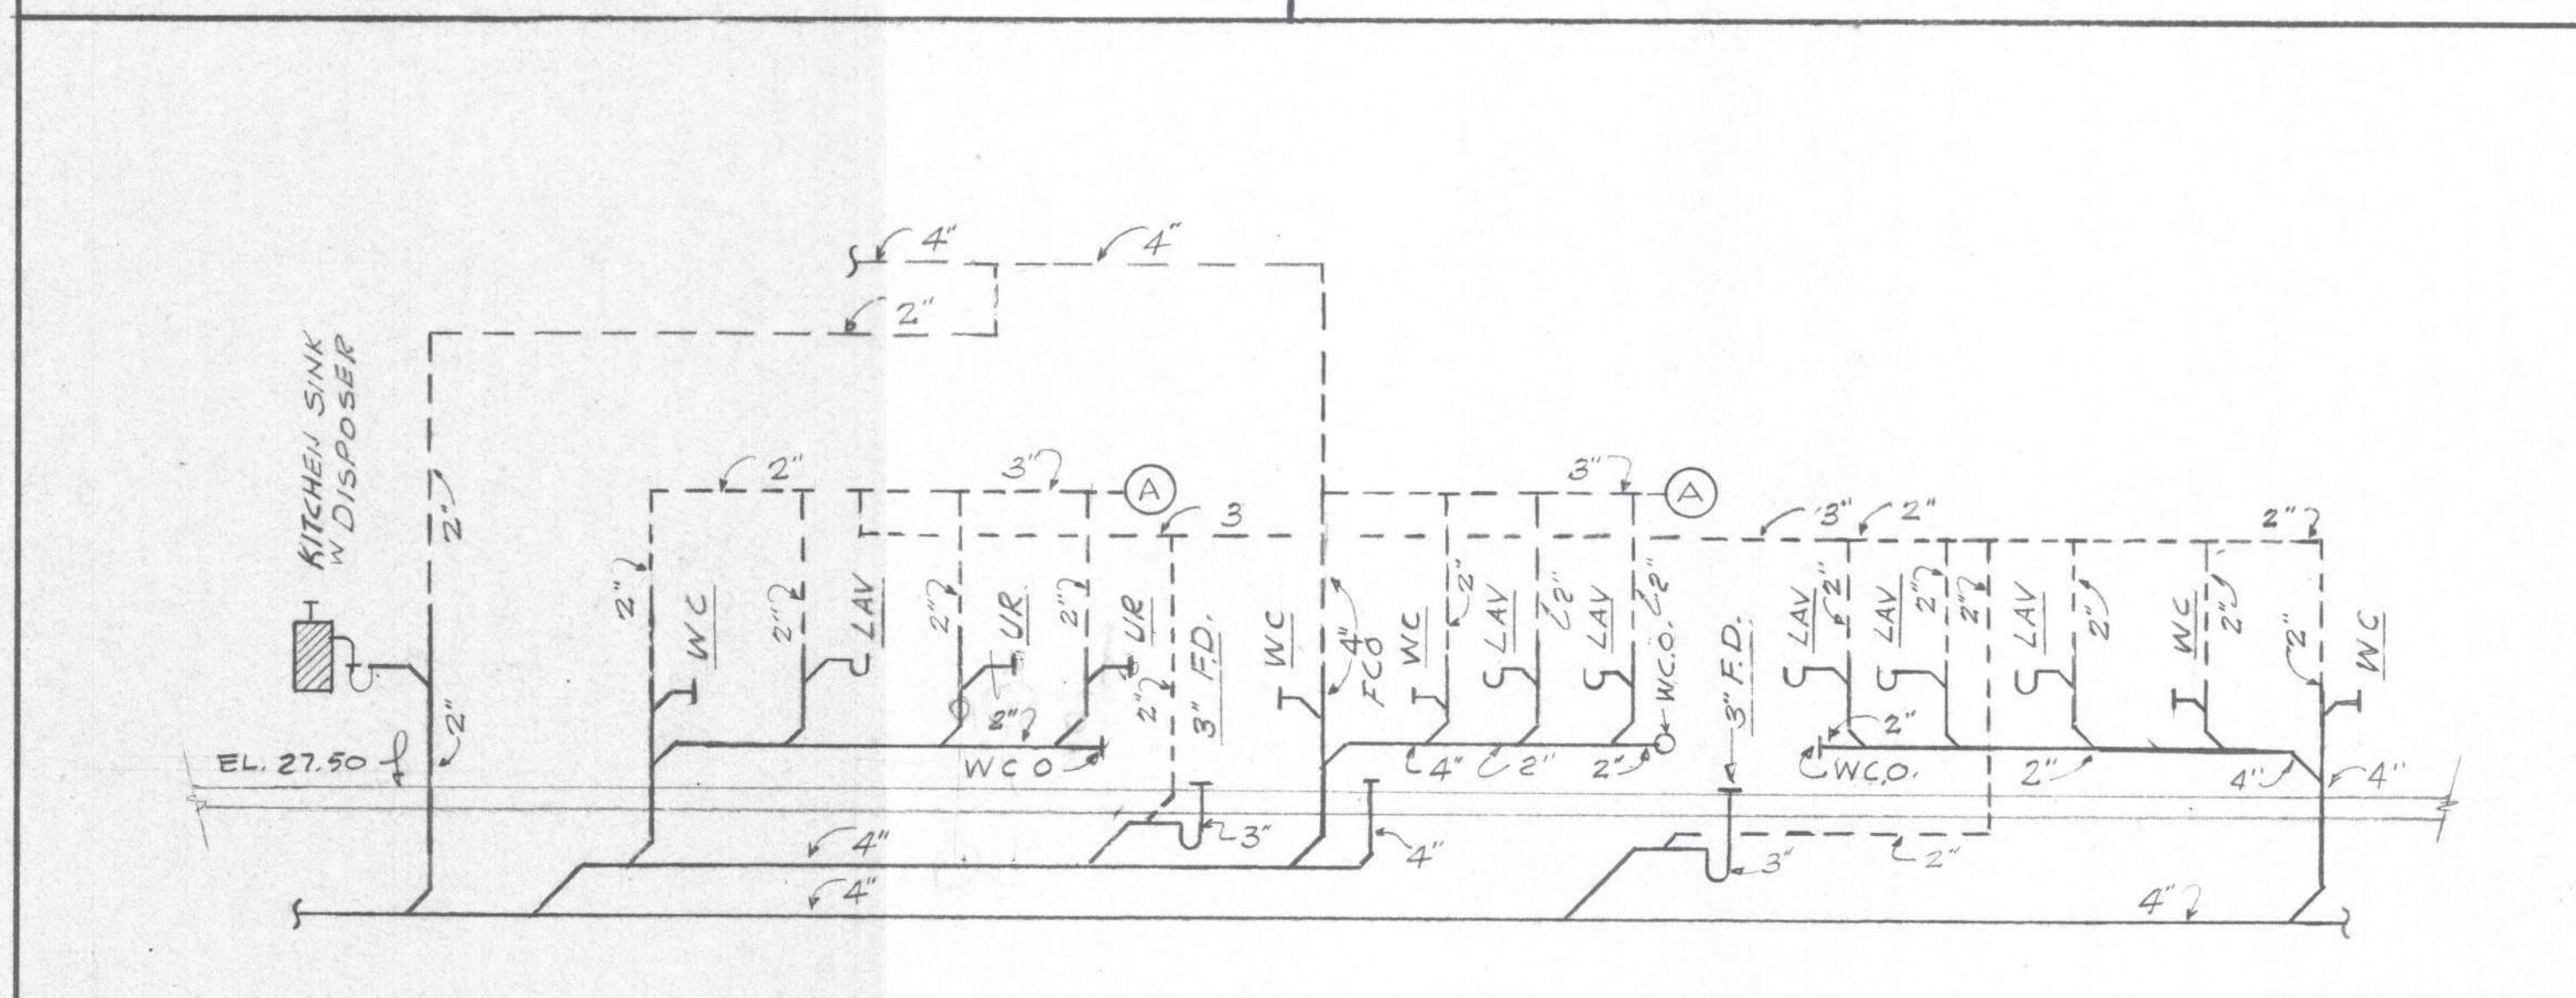

PART SOIL WASTE VENT PIPING DIAGRAM NO SCALE

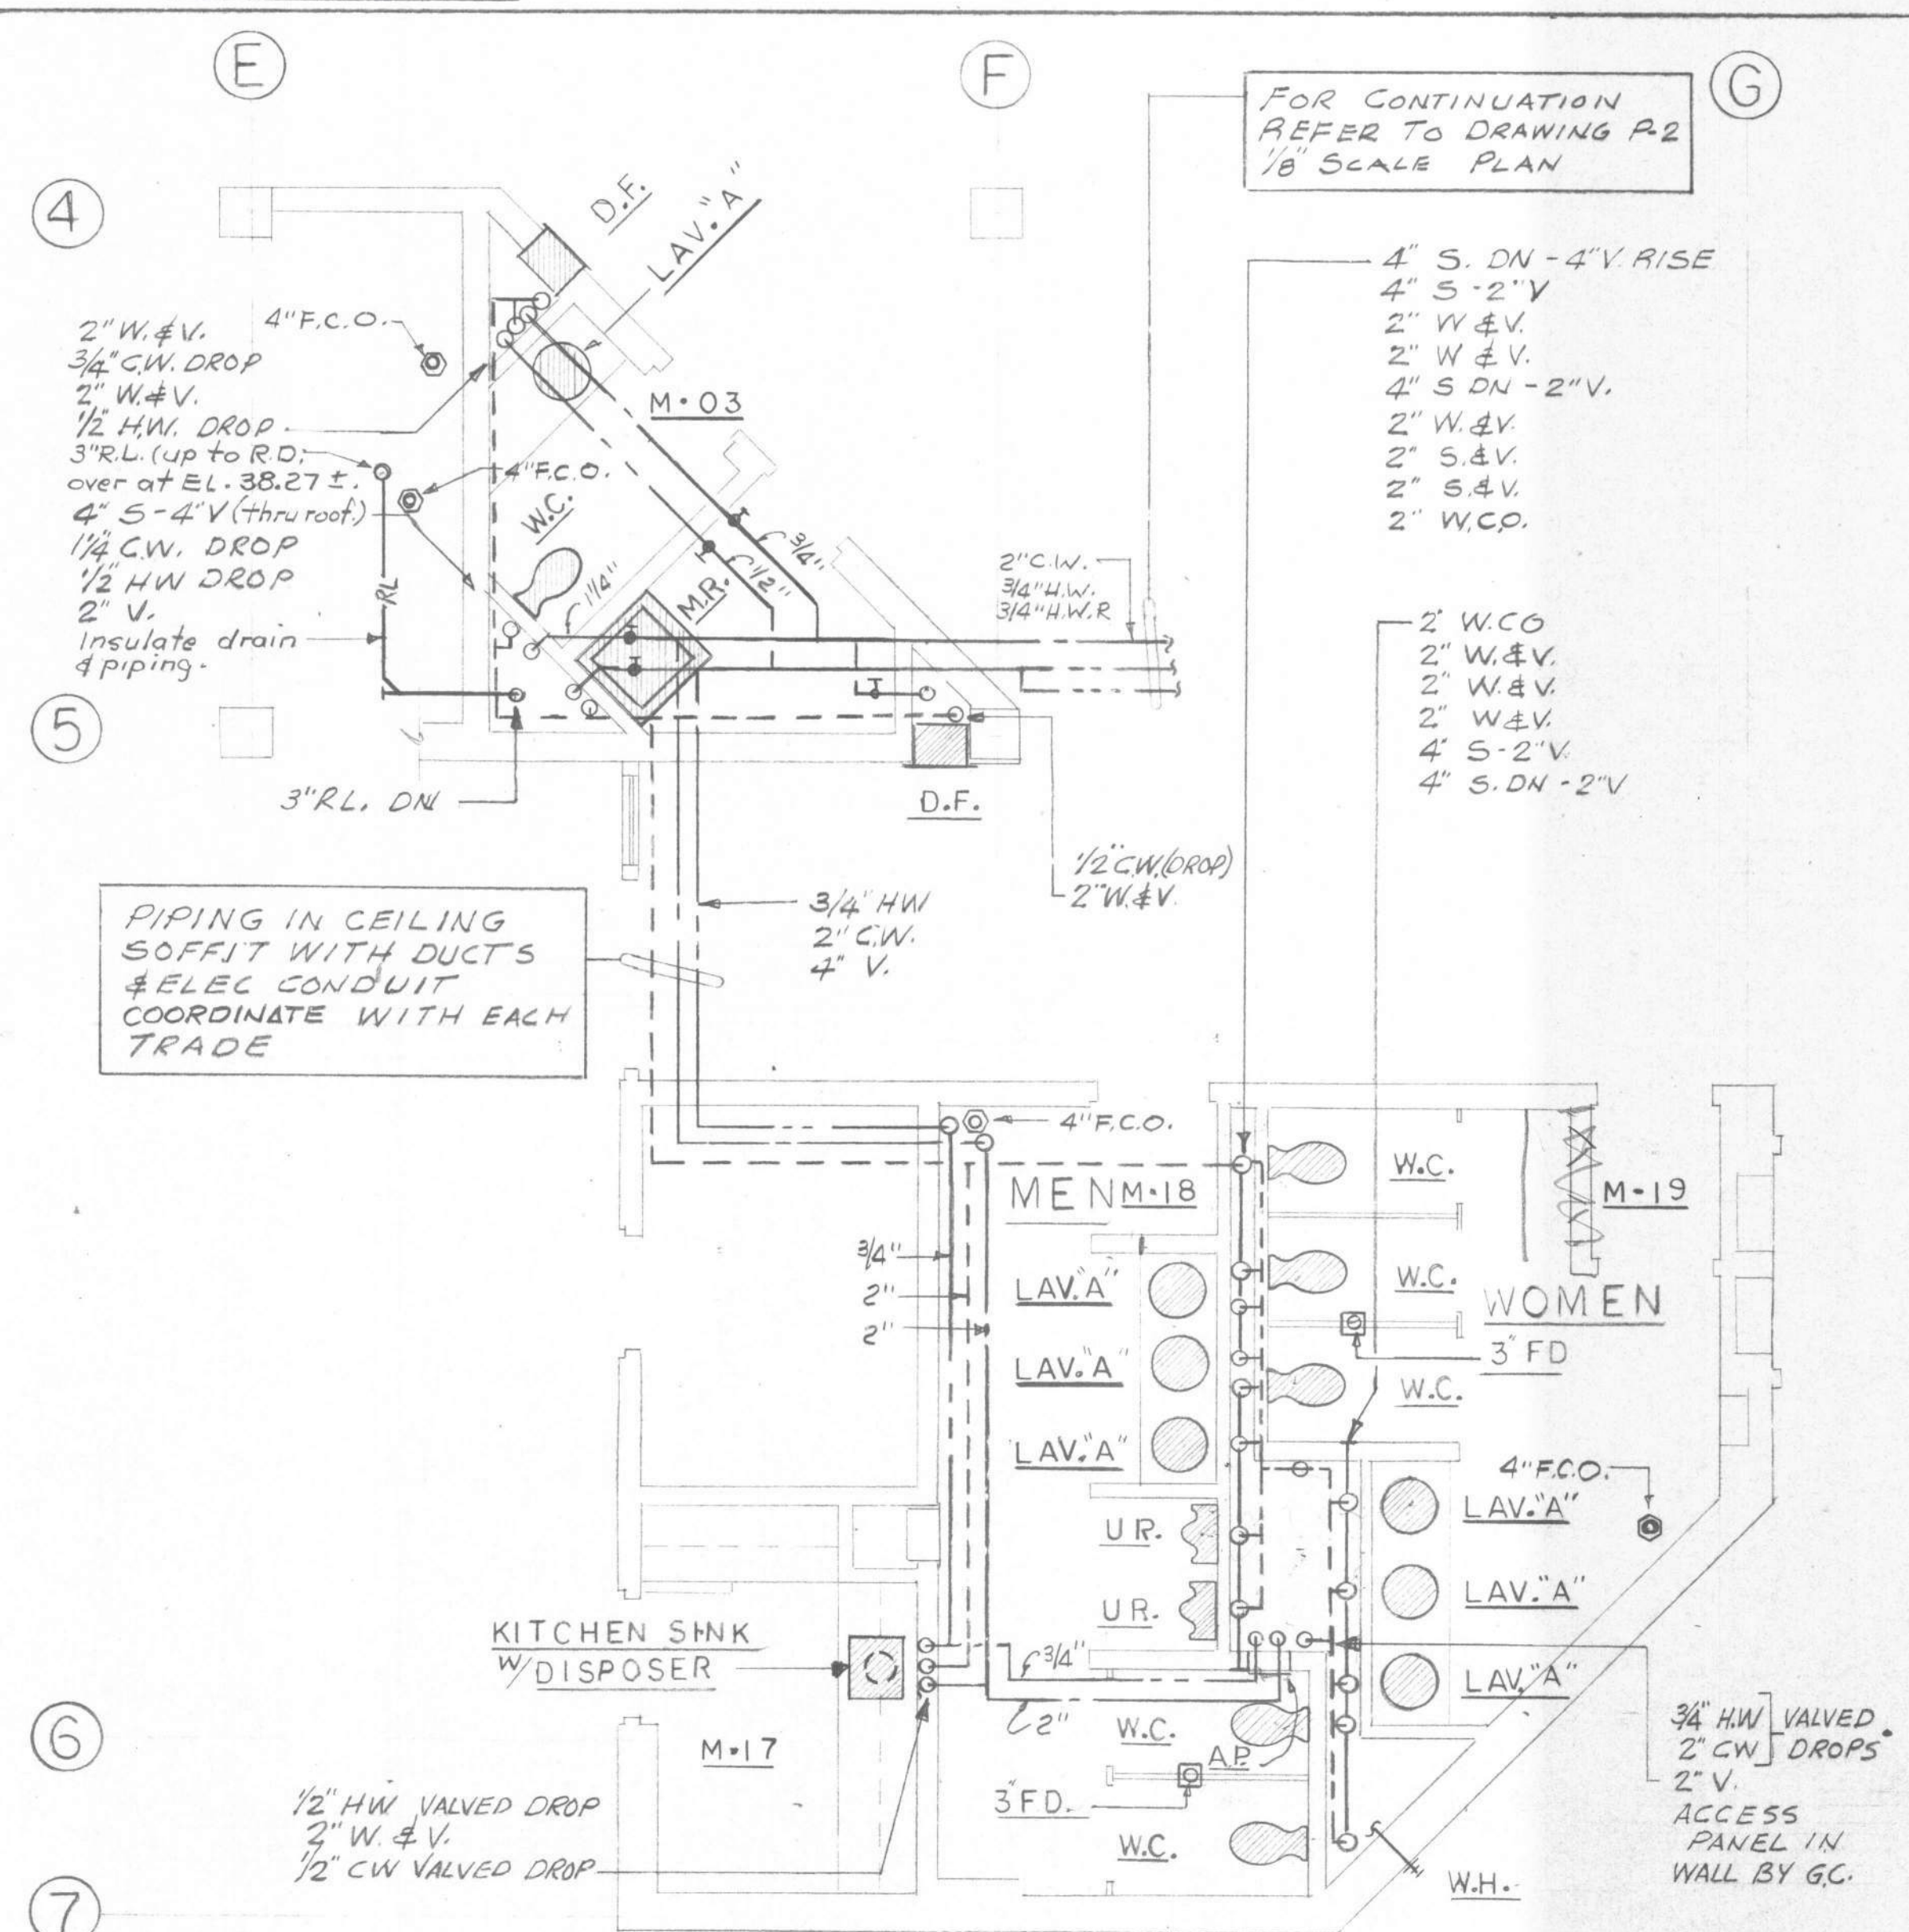

ENLARGED PLAN OF TOILET ROOMS SCALE 1/4"=1'-0"

NOTES

1. Add note to drawing P.2

TAC

THE ARCHITECTS COLLABORATIVE INC.
46 BRATTLE STREET, CAMBRIDGE
MASSACHUSETTS 02138

PROJECT TITLE

**N. KINGSTOWN
FREE LIBRARY**

PROJECT NO. 73006

DRAWN R.A.D. + R.F.B.

CHECK R.A.D.

SCALE AS NOTED

DATE

DRAWING TITLE

**DETAILS
AND
DIAGRAMS**

DRAWING NO.

P3

181-36

MARCH 5